

3F CEILING PLAN

SCALE
1/150

1



(주)디자인메소
서울시 강남구 언주로 136길 11 성원빌딩 3층
T. 02.3444.4536 / F. 02.3444.4539

Project Title

아주대학교 중앙도서관
복합학습공간(CLL) 조성공사

Consultant
Structure
Mechanical
Electrical
Civil & Landscaping

△			
△			
△			
△			
NO.	DATE	DESCRIPTION	APP.

Drawing Title

3F CEILING PLAN(전등공사)

Approved By

Drawn By

Checked By

File Name

Scale

Date

Note

1/150


2024.01.19

Drawing No.

I-102

Sheet No.

011

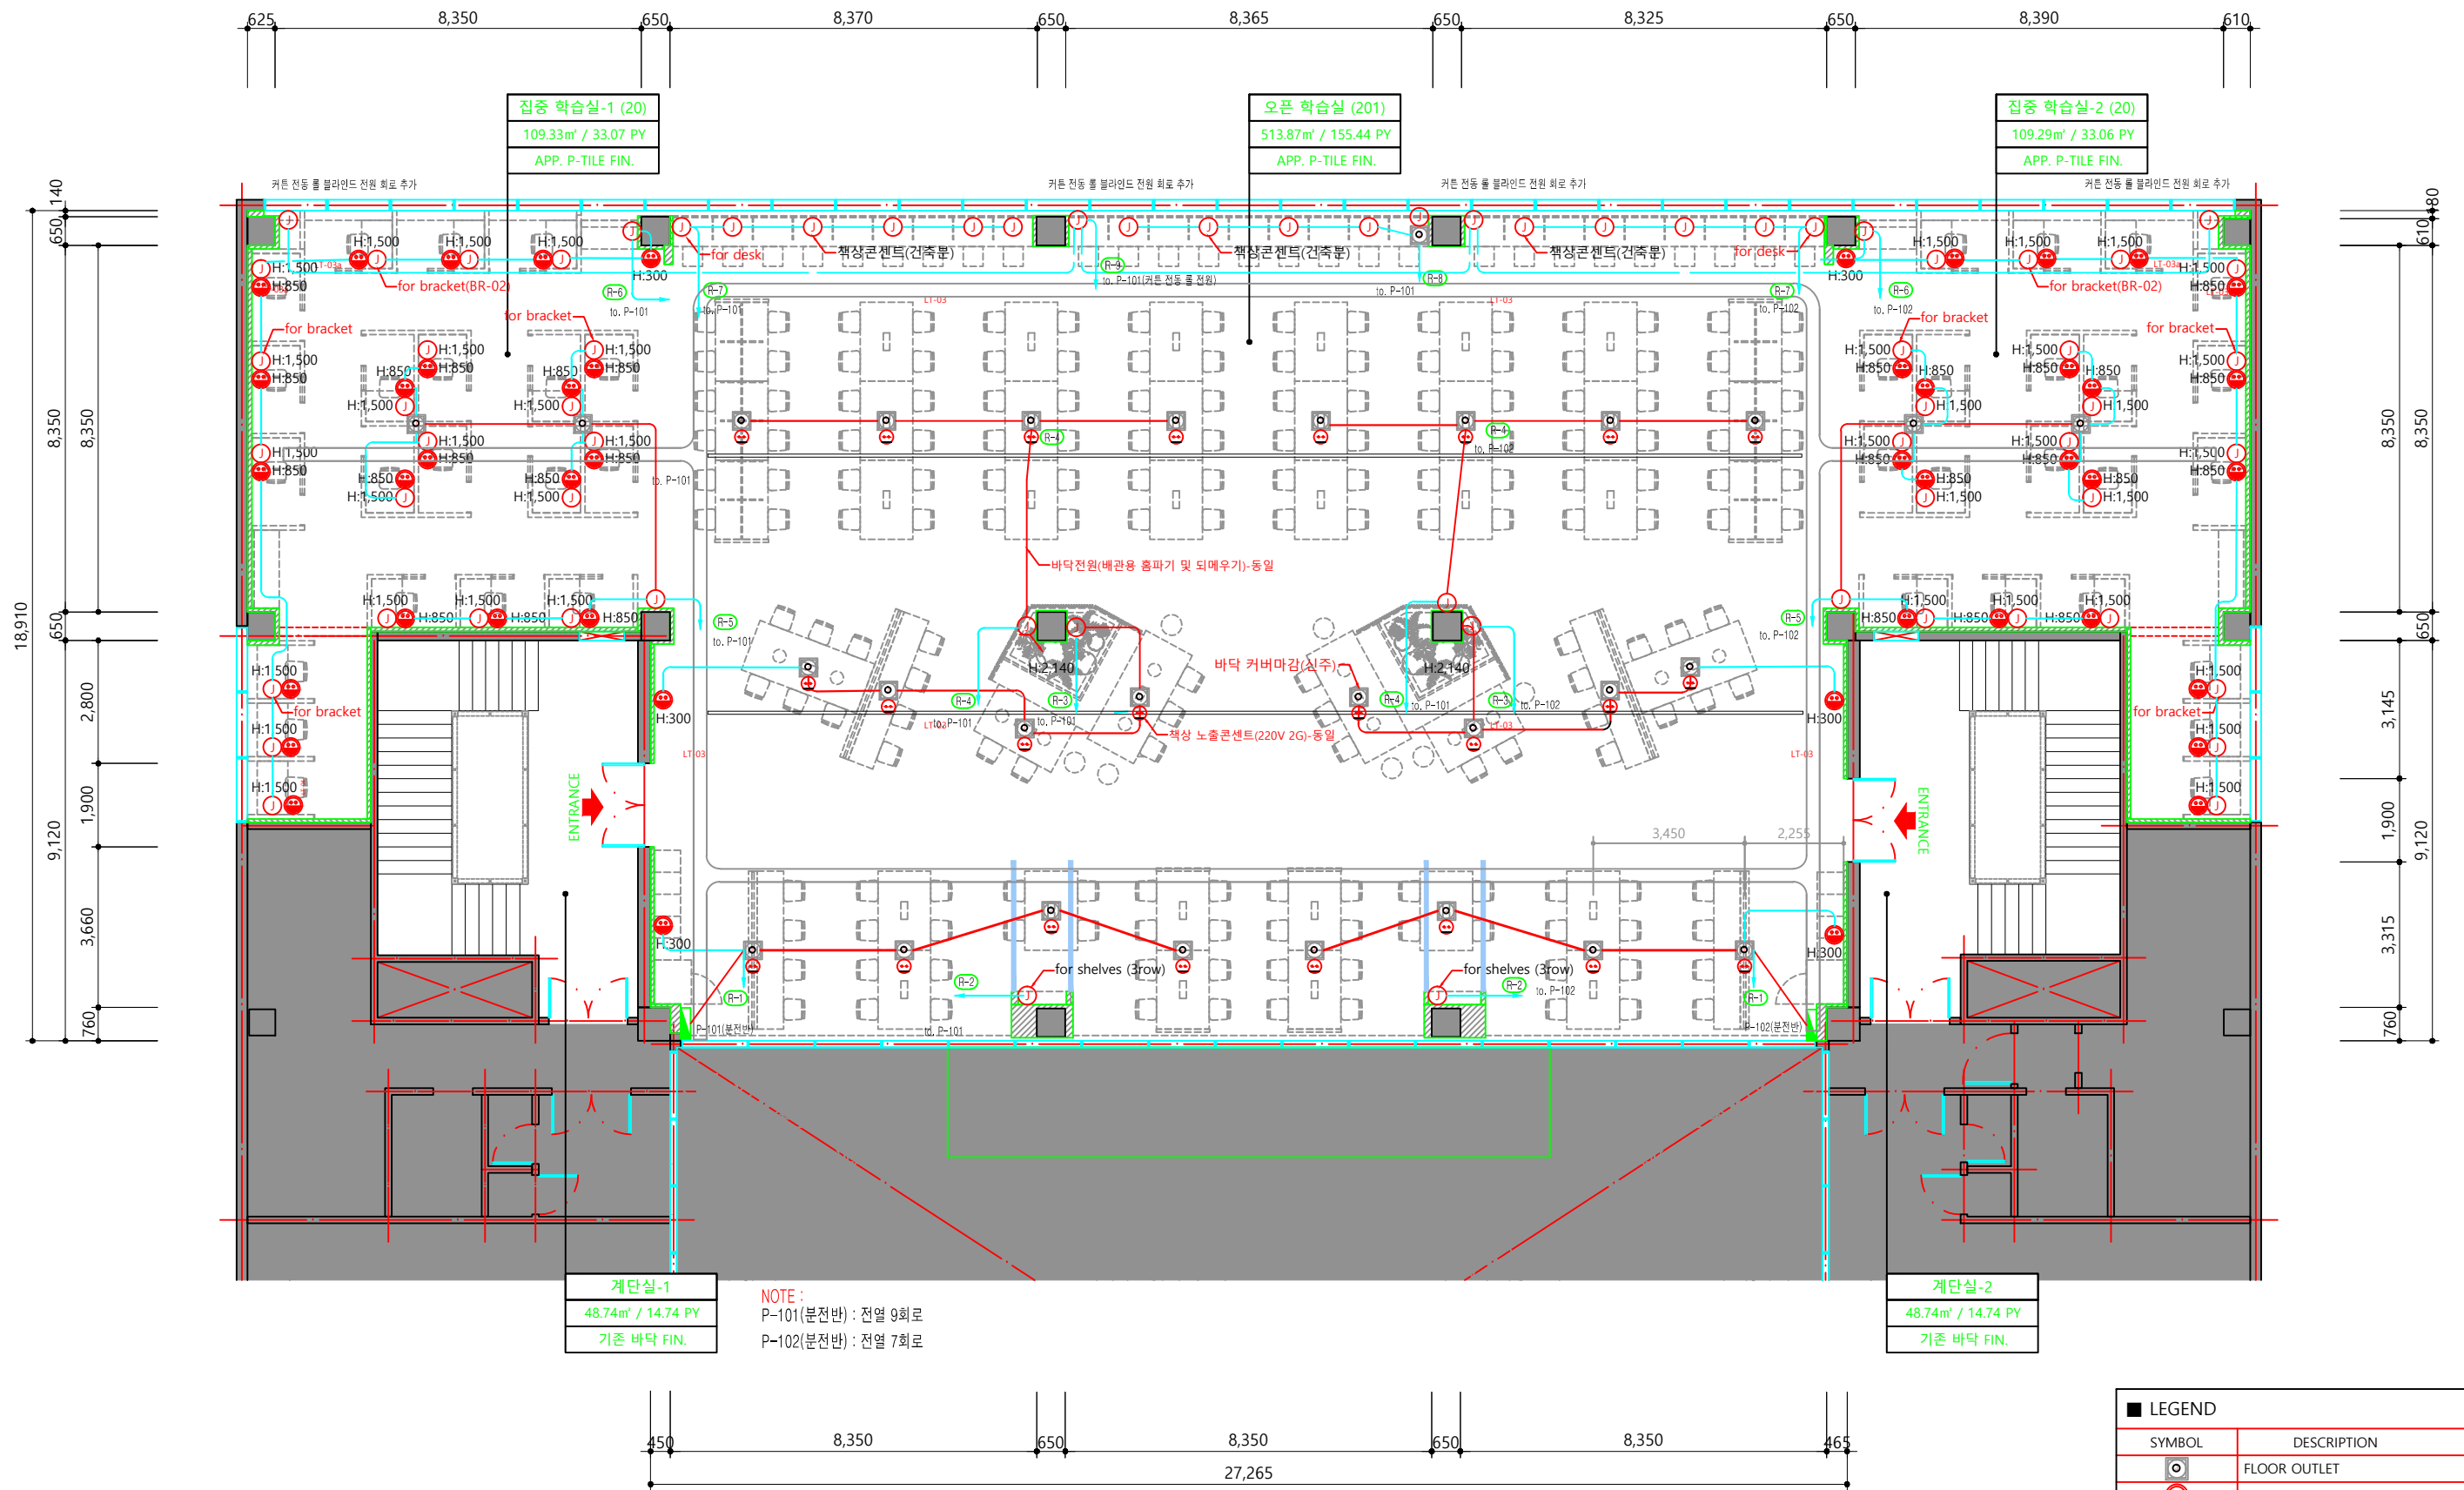

3F OUTLET PLAN

SCALE
1/150

1